


POINT	SIZE	DESCRIPTION
6557	36"	MAPLE
6555	6"	MAPLE
6593	5"	LILAC
6594	5"	LILAC
6600	36"	MAPLE
6605	12"	CEDAR
6606	12"	CEDAR
6652	6"	DECID SHRUB
6664	36"	MAPLE
6677	3"	BARBERRY
6687	27"	SPRUCE
6694	6"	DECID SHRUB
6361	30"	OAK

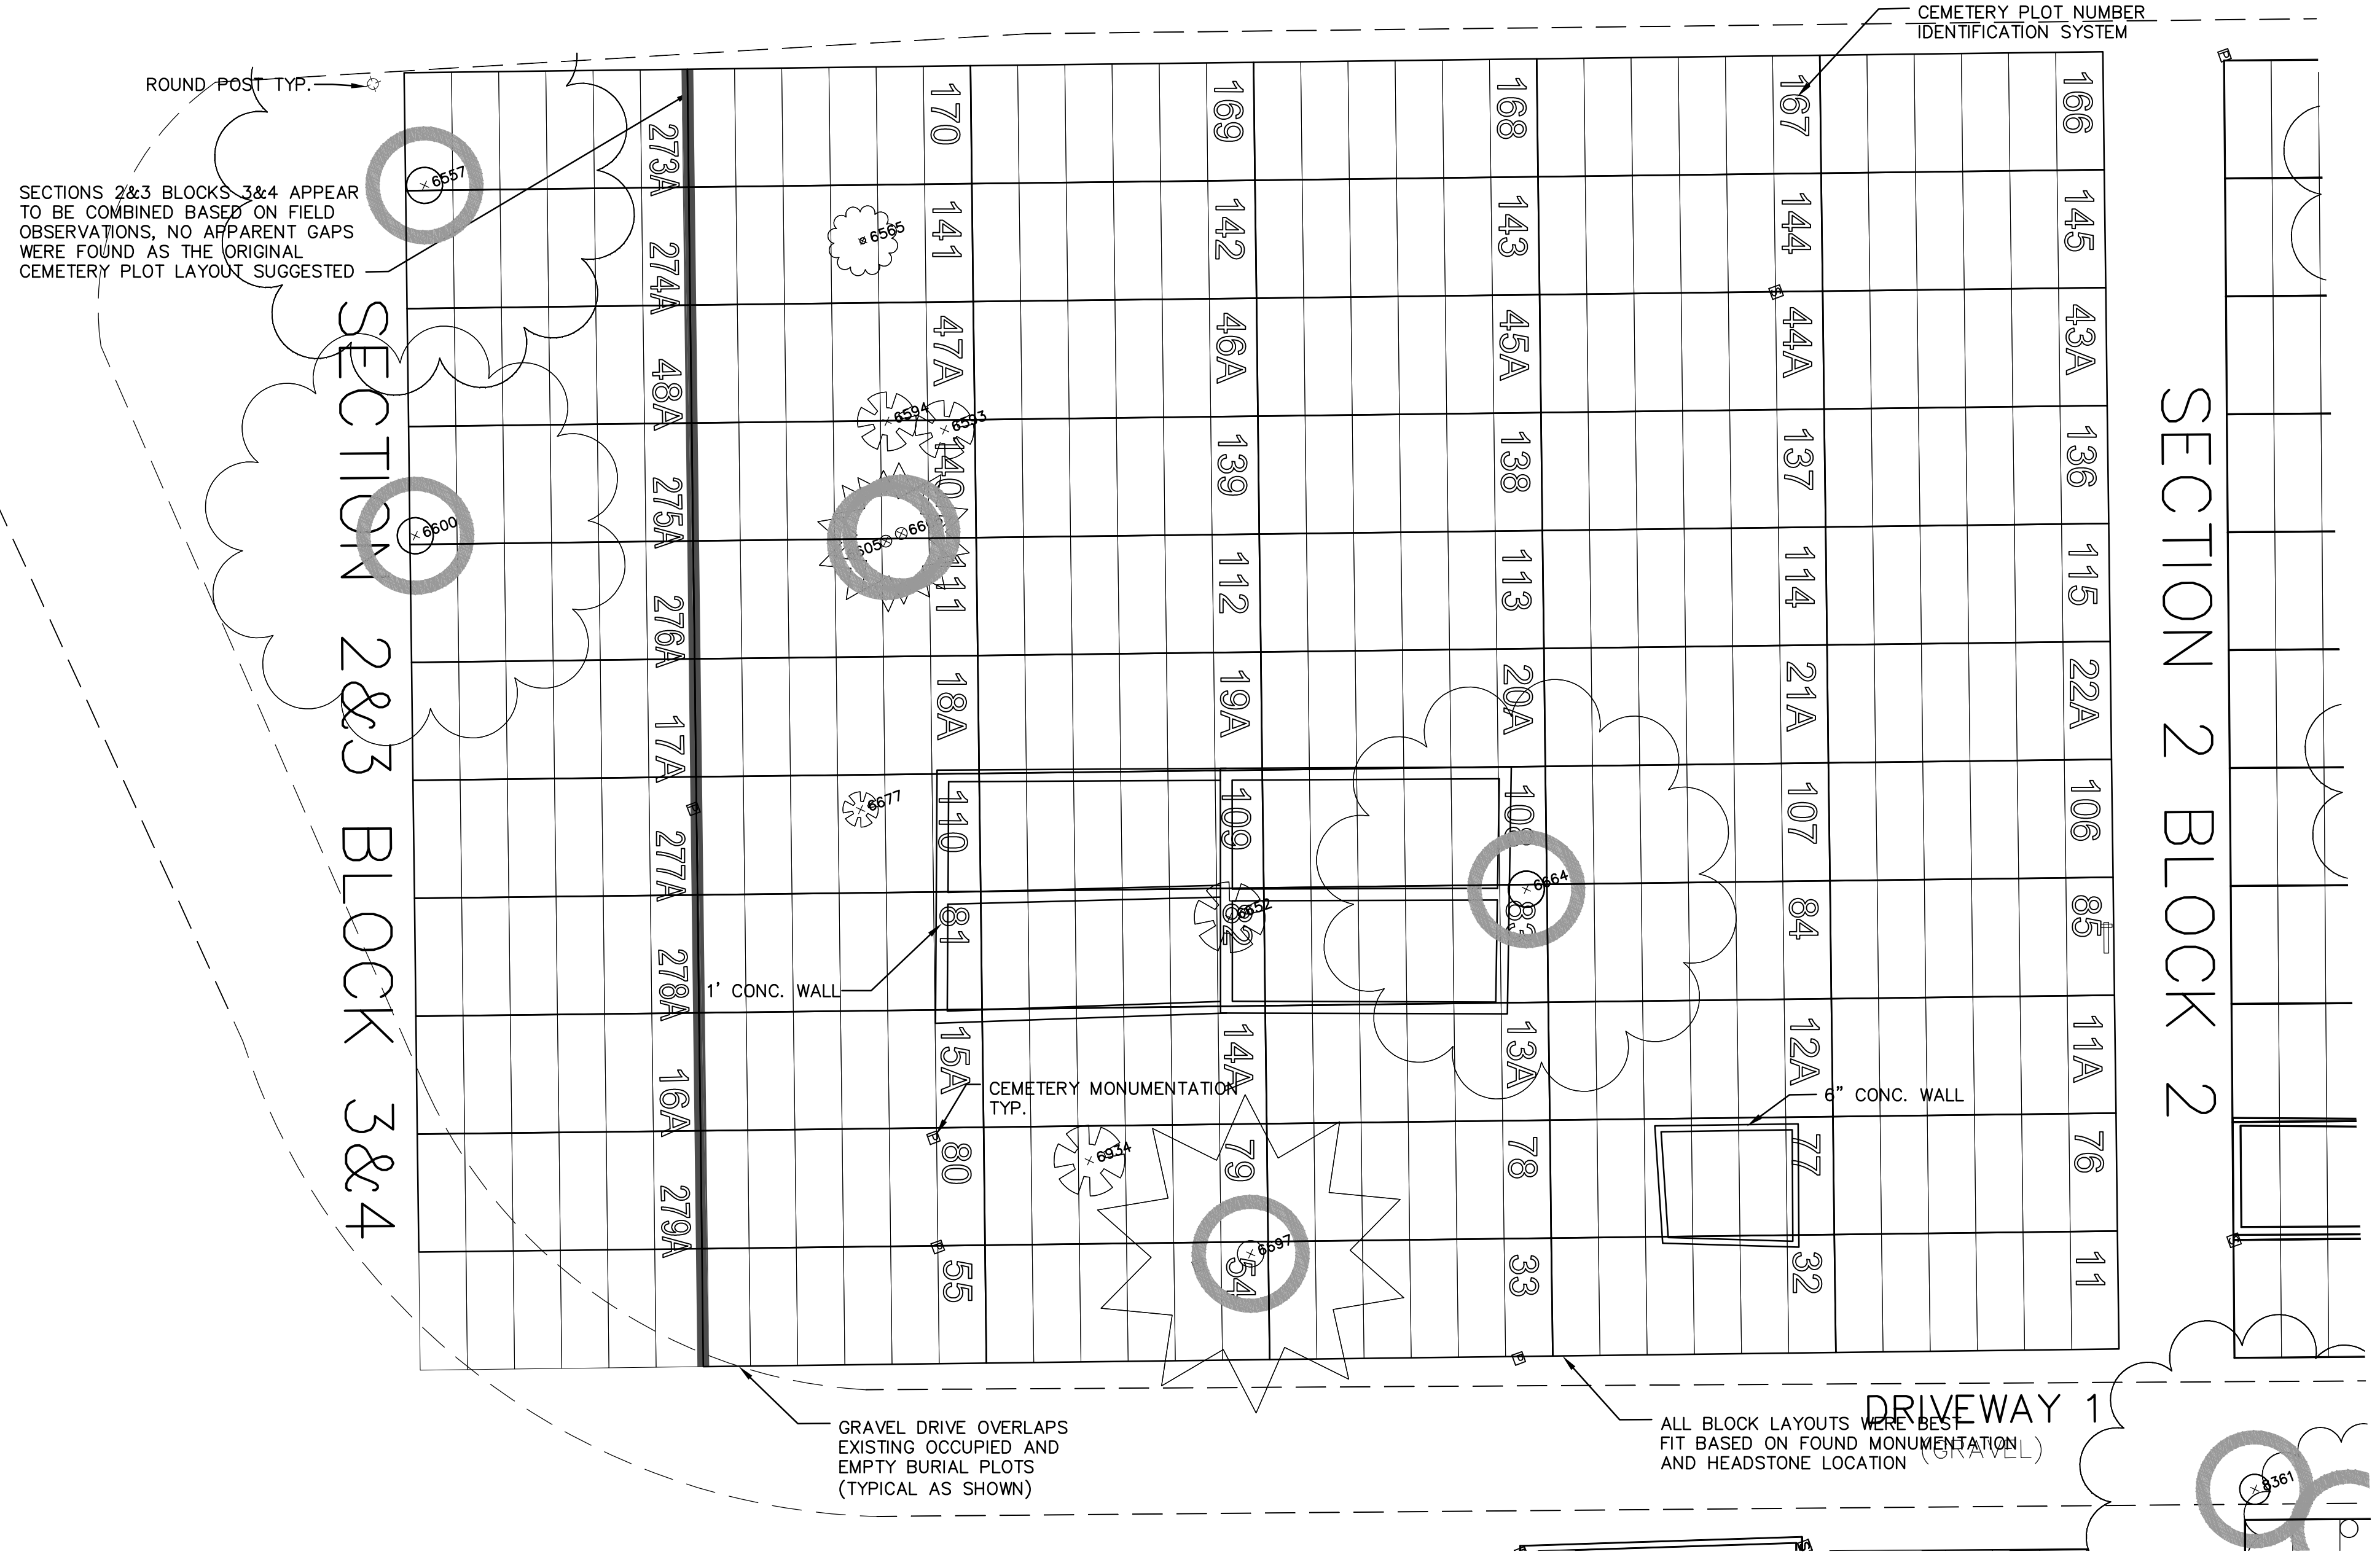

SECTIONS 2&3 BLOCKS 3&4 APPEAR TO BE COMBINED BASED ON FIELD OBSERVATIONS. NO APPARENT GAPS WERE FOUND AS THE ORIGINAL CEMETERY PLOT LAYOUT SUGGESTED

LEGEND	
	HEADSTONE (SHOWN IN MAGNITUDE) CLASSIFIED INTO 3 SIZES LG, MED, SM (ARROW INDICATES FRONT OF HEADSTONE)
	ROUND HEADED BOLT W/ PLATE
	4" ROUND PLATE W/ 2 LOT NUM.
	5" SQUARE PLATE W/ 4 LOT NUM.
	4" X 4" STONE POST
	6" X 6" GRANITE POST
	ROADWAY SIGN
	FAMILY PLOT MARKER OF VARYING DIMENSIONS AS SHOWN
	UNMARKED HEADSTONE
	10' BUFFER AROUND TREES
	BENCH
	FOUND IRON ROD
	FOUND MONUMENT
	WATER METER
	WATER WELL
	WATER PUMP
	ELECTRICAL RISER
	FENCE LINE

REV.	DESCRIPTION
6-28-07	FINAL PLOT
7-8-05	RENUMBER PARTS OF SECTIONS 5 & 6
3-2005	ORIGINAL ISSUE

DRAWN BY: CWN CHECKED BY: FRZ SEALED:

NOTE:
THE LOT LINES SHOWN ARE APPROXIMATE BASED ON FIELD INFORMATION.
DO NOT USE FOR CONSTRUCTION.

VILLAGE OF PINCKNEY CEMETERY
PINCKNEY, MICHIGAN

CEMETERY LAYOUT
SECTIONS 2&3 BLOCKS 3&4

AYRES, LEWIS, NORRIS & MAY, INC.
engineers • planners • surveyors
3959 Research Park Drive
Ann Arbor, Michigan 48108
(734) 761-1010 phone (734) 761-1200 fax

PROJECT NUMBER: 230819.00 SHEET NUMBER: 007