
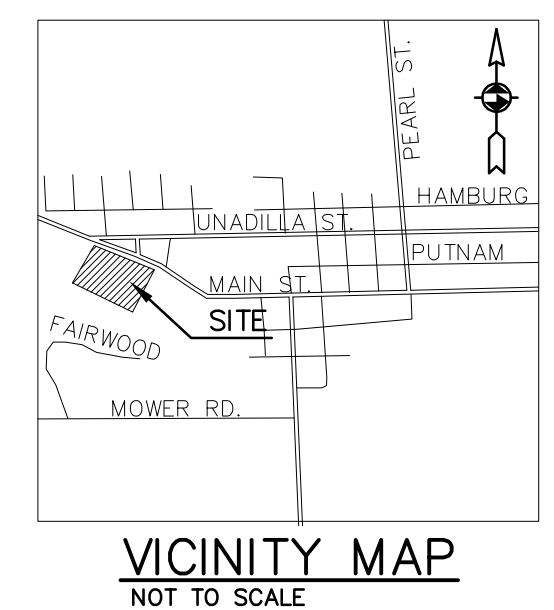
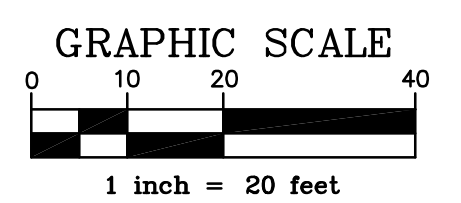
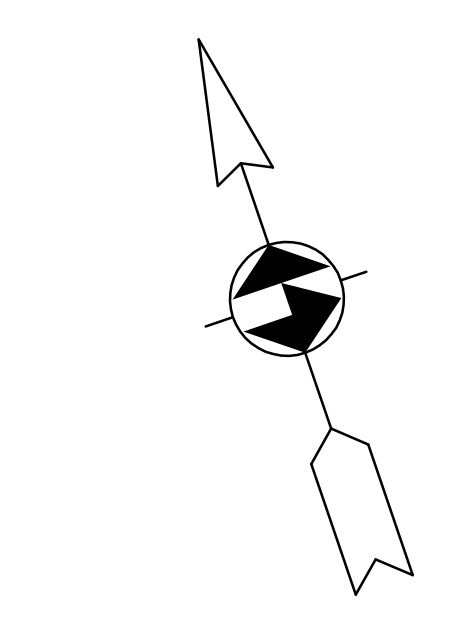


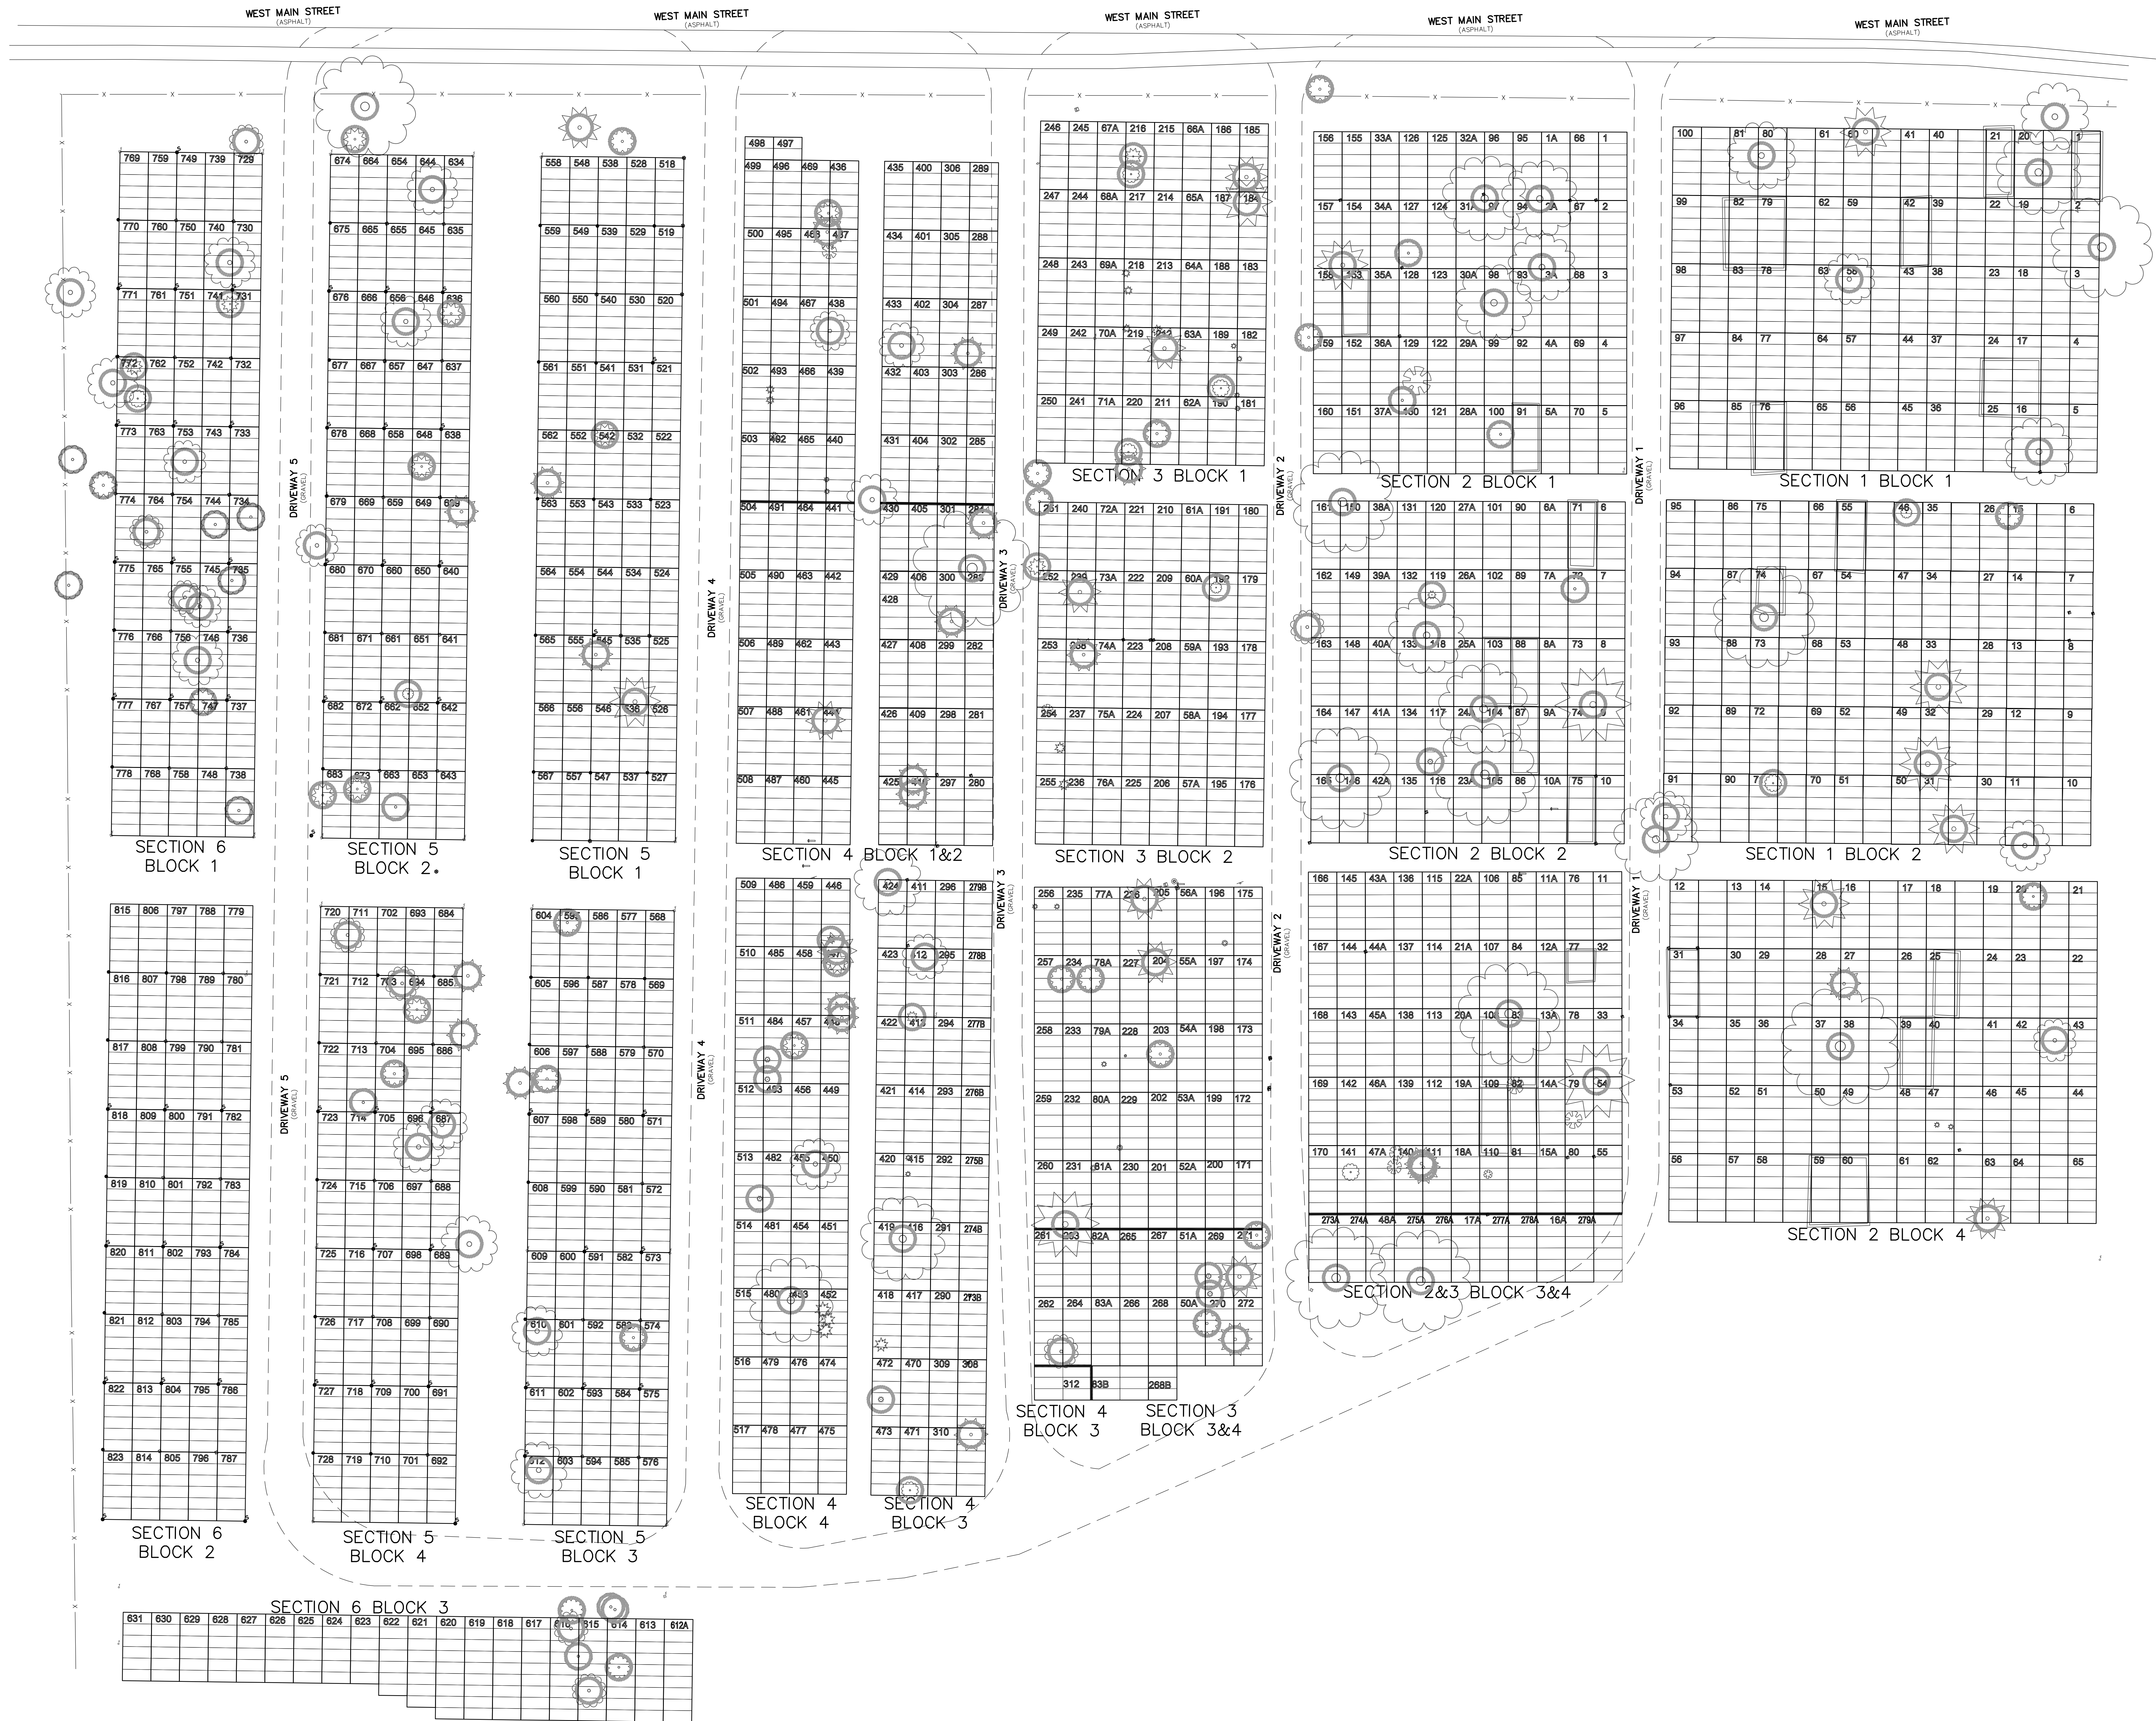

LEGEND	
	TYPICAL BURIAL PLOT 10' LONG X 4' WIDE
	ROUND HEADED BOLT W/ PLATE
	4" ROUND PLATE W/ 2 LOT NUM.
	5" SQUARE PLATE W/ 4 LOT NUM.
	4" X 4" STONE POST
	6" X 6" GRANITE POST
	EXIST ROADWAY SIGN
	WATER METER
	WATER WELL
	WATER PUMP
	ELECTRICAL RISER
	EXIST FENCE LINE

REV.	DESCRIPTION
REV.	TYPICAL BURIAL PLOT 10' LONG X 4' WIDE
REV.	WATER METER
REV.	WATER WELL
REV.	WATER PUMP
REV.	ELECTRICAL RISER
REV.	EXIST ROADWAY SIGN
REV.	EXIST FENCE LINE

NOTE:
THE LOT LINES SHOWN ARE APPROXIMATE BASED ON FIELD INFORMATION.
DO NOT USE FOR CONSTRUCTION.

VILLAGE OF PINCKNEY CEMETERY
PINCKNEY, MICHIGAN
CEMETERY LAYOUT

3 WORKING DAYS
BEFORE YOU DIG
CALL MISS DIG
1-800-482-7171
FOR THE LOCATION OF UNDERGROUND UTILITIES

NOTE:
THE LOCATIONS AND ELEVATIONS OF
EXISTING UNDERGROUND UTILITIES AS SHOWN
ON THIS DRAWING ARE ONLY APPROXIMATE.
NO GUARANTEE IS EITHER EXPRESSED OR
IMPLIED AS TO THE COMPLETENESS OR
ACCURACY THEREOF. THE CONTRACTOR
SHALL BE RESPONSIBLE FOR CONTACTING
MISS DIG PRIOR TO CONSTRUCTION.

PROJECT NUMBER
230819.00

SHEET NUMBER
001