



POINT	SIZE	DESCRIPTION
3240	20"	OAK
3241	16"	OAK
3242	16"	OAK
3243	10"	OAK
3244	10"	CEDAR
3245	12"	CEDAR
3246	8"	CEDAR
3247	12"	CEDAR
3248	12"	CHERRY
3249	12"	CHERRY
7896	8"	OAK
7897	10"	OAK
7898	10"	OAK
7899	12"	CHERRY
7900	10"	CHERRY
7901	12"	OAK
7902	8"	HICKORY

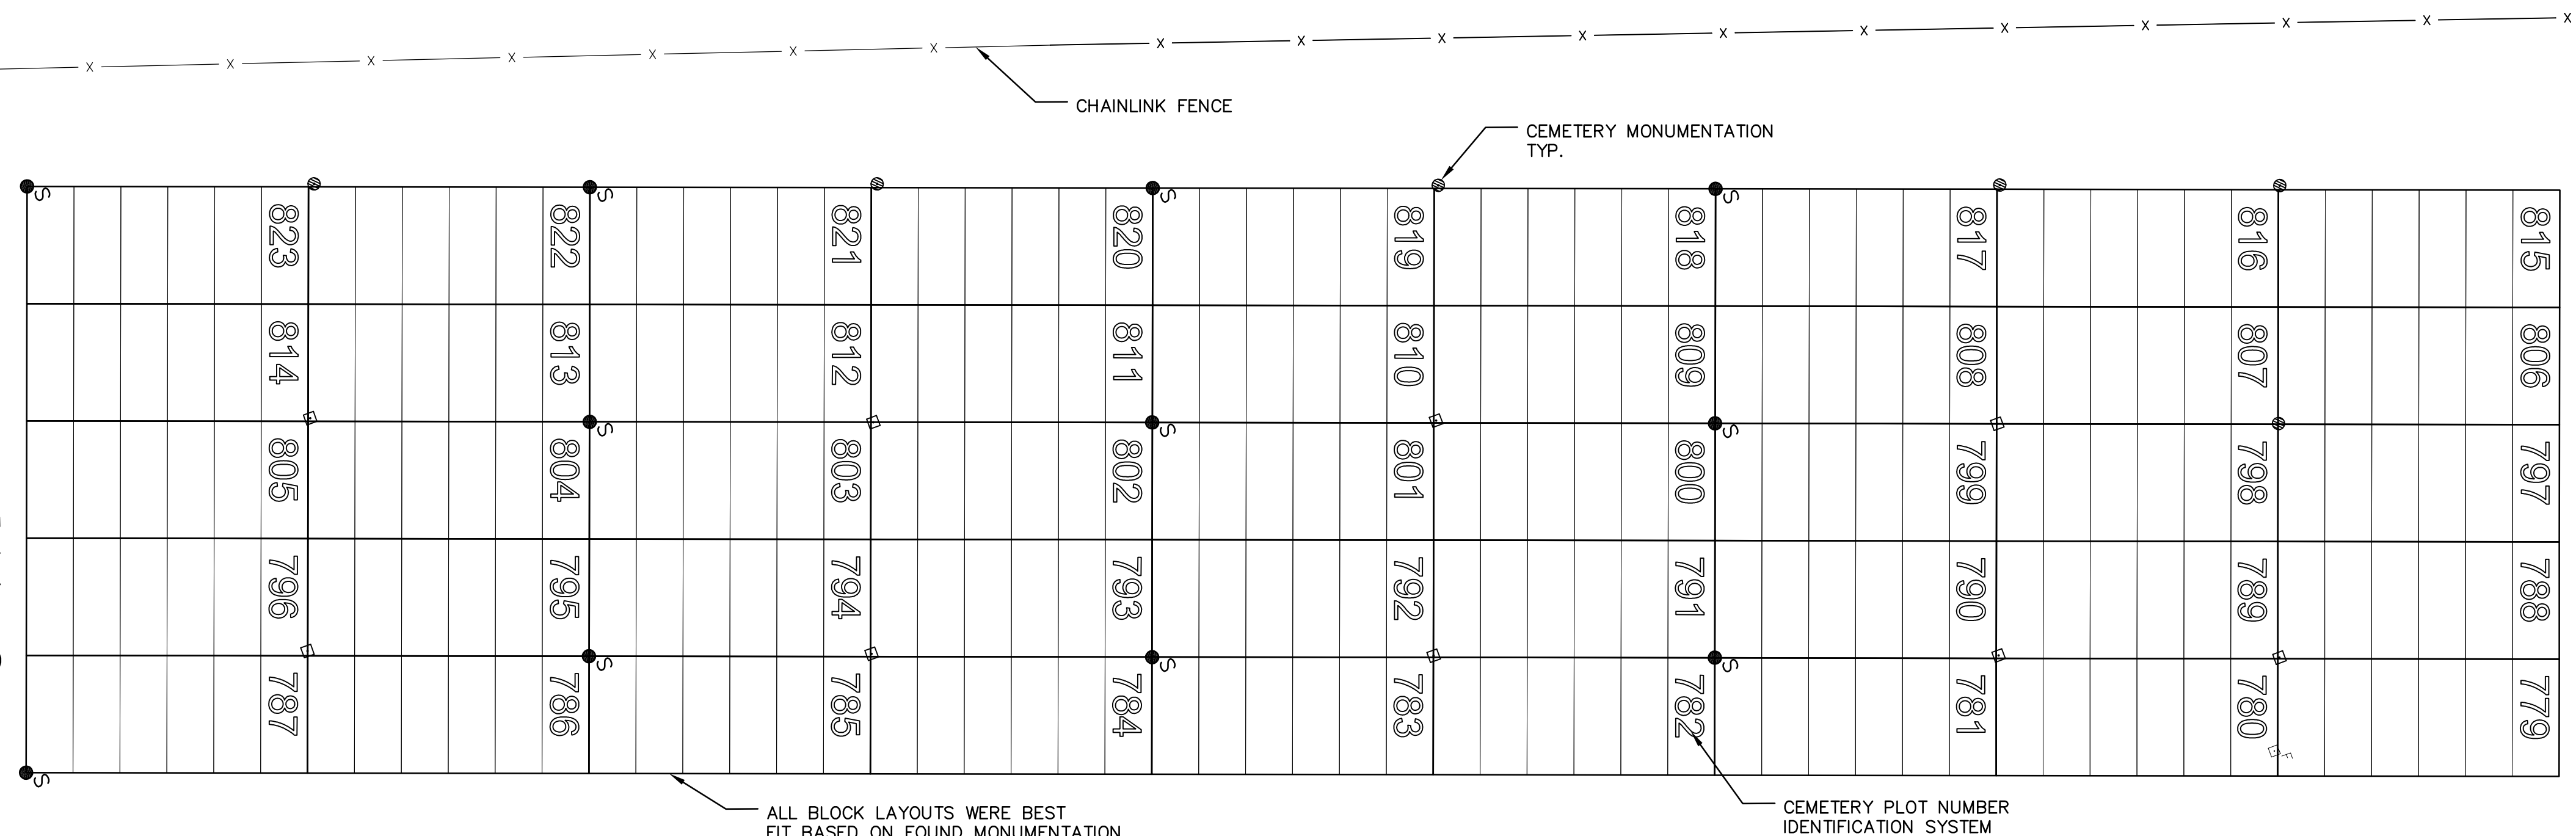

SECTION 6 BLOCK 3 ALIGNMENT BASED ON EXISTING HEADSTONES THE FOUND MONUMENTATION DOES NOT FIT THE BLOCK PROPERLY

SECTION 6
BLOCK 2


SECTION 5
BLOCK 4

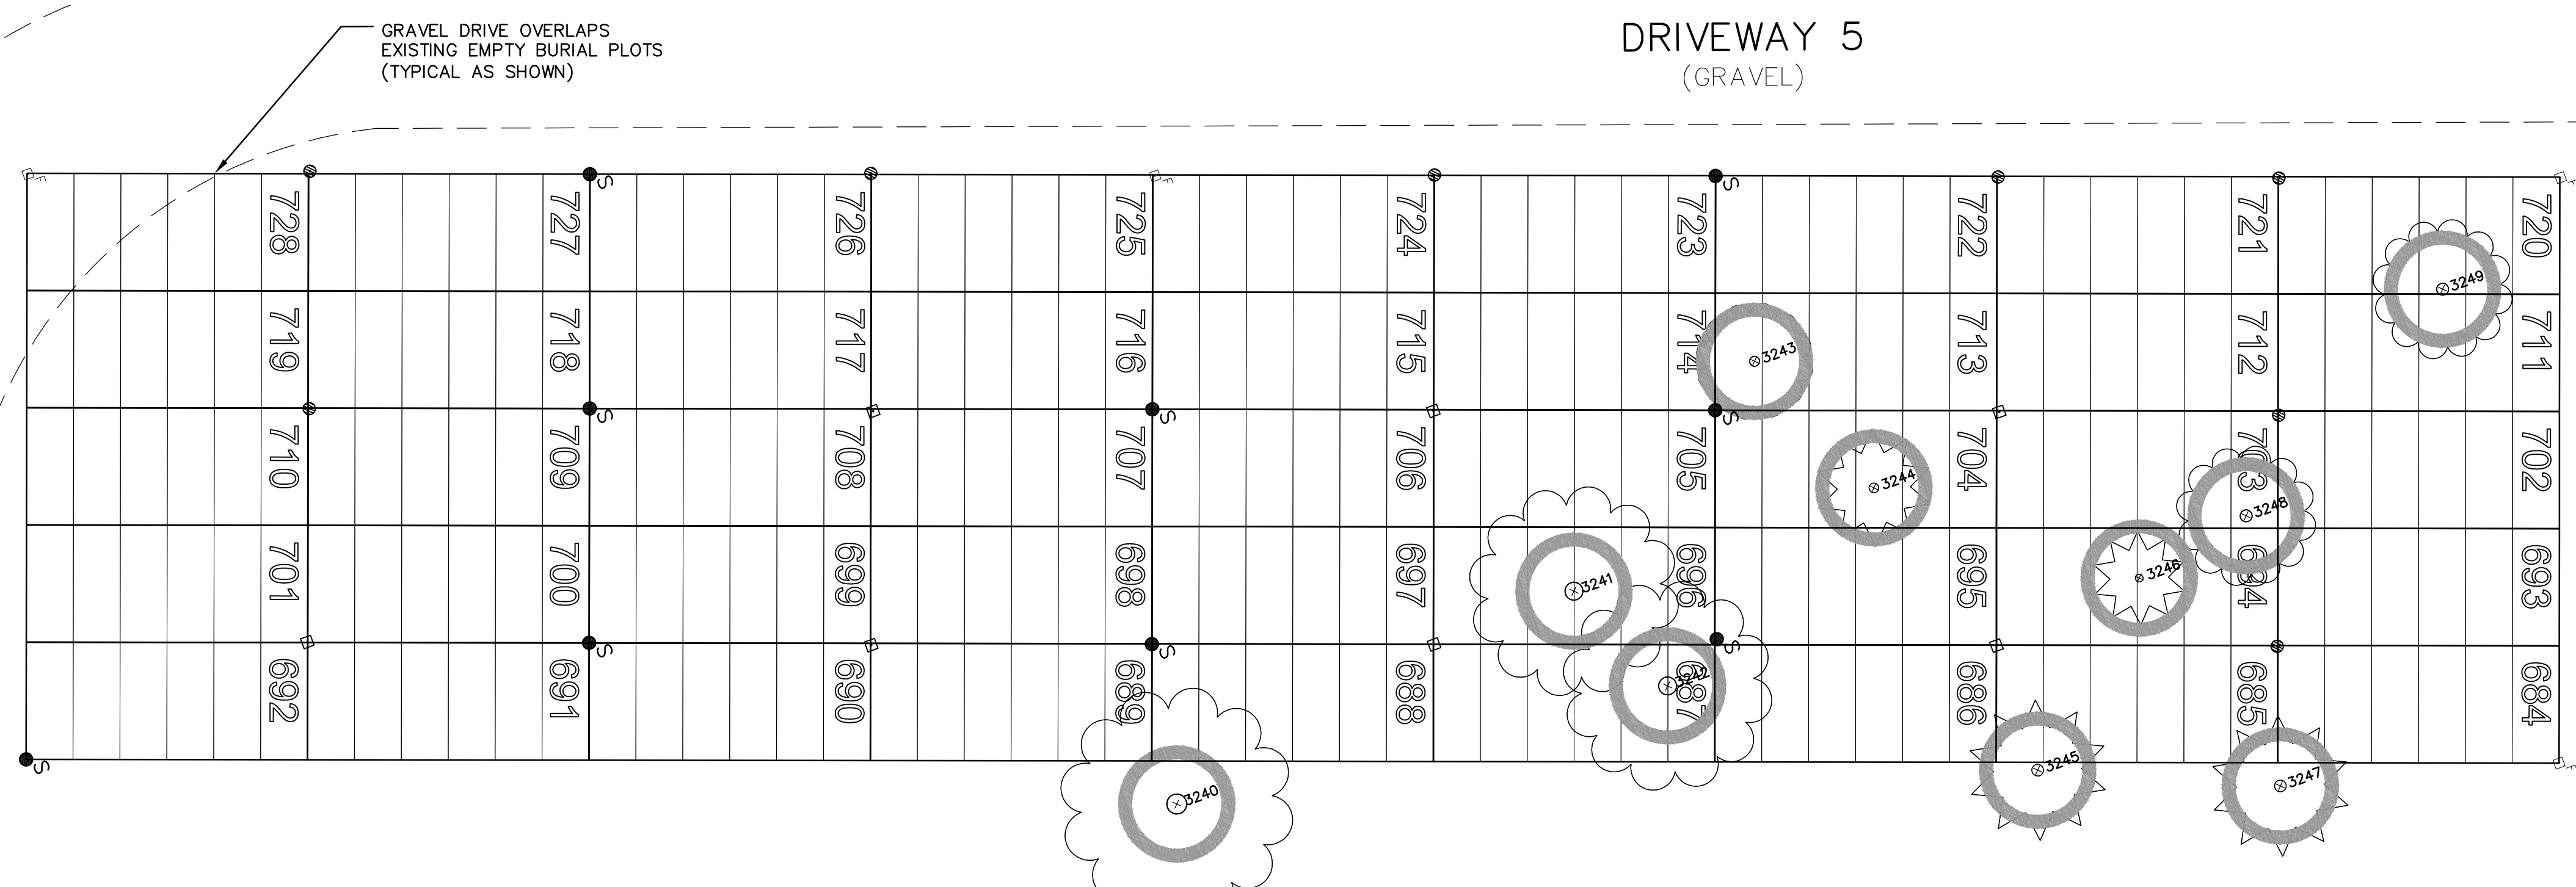

DRIVEWAY 5
(GRAVEL)

SECTION 6 BLOCK 3

631 630 629 628 627 626 625 624 623 622 621 620 619 618 617 616 615 614 613 612A

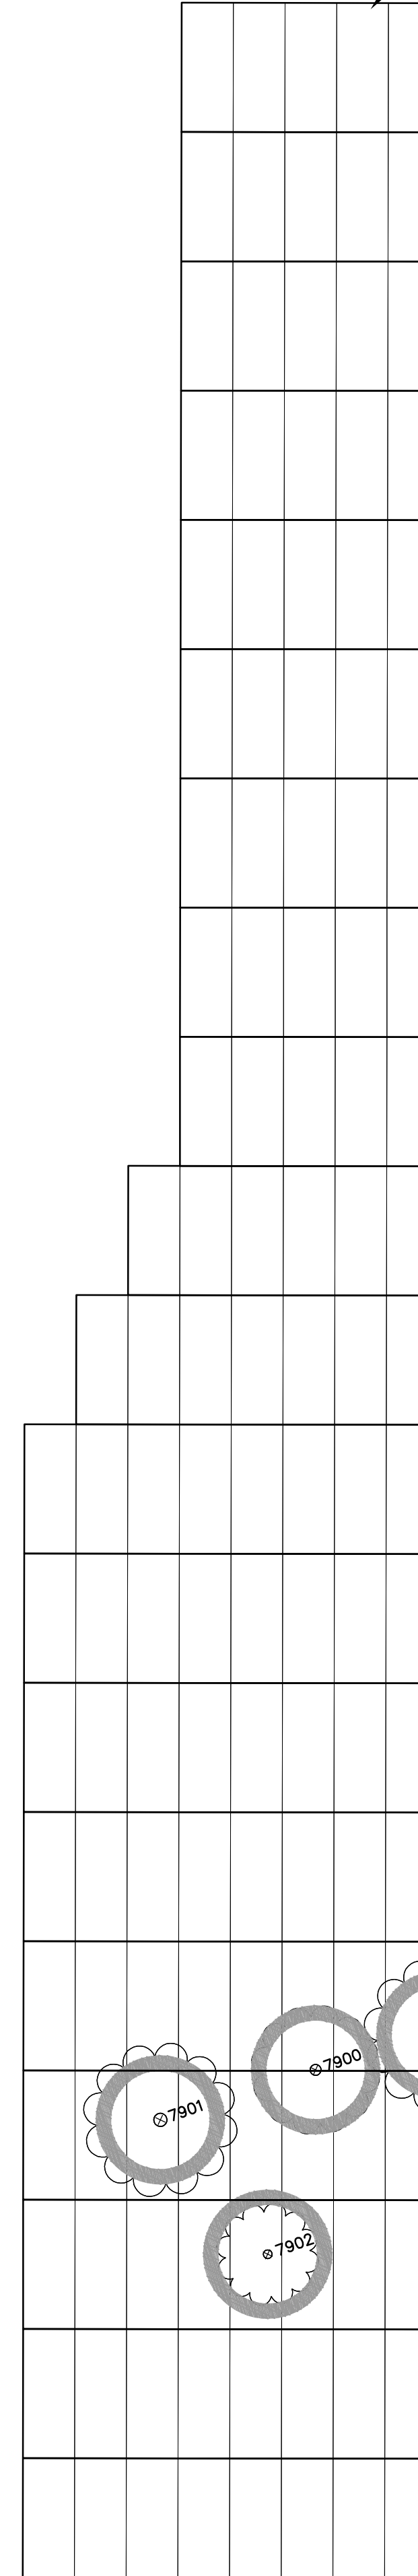

NOTE:
THE LOT LINES SHOWN ARE APPROXIMATE BASED ON FIELD INFORMATION.
DO NOT USE FOR CONSTRUCTION.

LEGEND	
HEADSTONE (SHOWN IN MAGNITUDE) CLASSIFIED INTO 3 SIZES LG, MED, SM (ARROW INDICATES FRONT OF HEADSTONE)	FAMILY PLOT MARKER OF VARYING DIMENSIONS AS SHOWN
ROUND HEADED BOLT W/ PLATE	10' ϕ BUFFER AROUND TREES
4" ROUND PLATE W/ 2 LOT NUM.	UNMARKED HEADSTONE
5" SQUARE PLATE W/ 4 LOT NUM.	WATER METER
4" X 4" STONE POST	WATER WELL
6" X 6" GRANITE POST	BENCH
FOUND IRON ROD	WATER PUMP
FOUND MONUMENT	ELECTRICAL RISER
ROADWAY SIGN	FENCE LINE

REV.	
REV.	
REV.	
REV.	
REV.	6-28-07 FINAL PLOT
REV.	7-8-05 RENUMBER PARTS OF SECTIONS 5 & 6
REV.	3-2005 ORIGINAL ISSUE
DRAWN BY:	CWN
CHECKED BY:	FRZ
SEALED:	

VILLAGE OF PINCKNEY CEMETERY
PINCKNEY, MICHIGAN

CEMETERY LAYOUT
SECTIONS 5&6 BLOCKS 2,3&4

AYRES, LEWIS, NORRIS & MAY, INC.
engineers · planners · surveyors
3959 Research Park Drive
Ann Arbor, Michigan 48108
(734) 761-1010 phone (734) 761-1200 fax

PROJECT NUMBER: 230819.00
SHEET NUMBER: 002